



 
DUNWOODY HIGH SCHOOL - CONCESSIONS
5035 VERMACK RD
DUNWOODY, GA 30338




SEAL

3D VIEWS

A0.1



FOUNDATION PLAN LEGEND

 	CONCRETE SLAB-ON-GRADE
	WOOD FRAMED WALLS - SEE FLOOR PLANS
	SLAB STEP - SEE CIVIL
	FD: FLOOR DRAIN - REFER TO PLUMBING DRAWINGS FOR SIZING, LOCATIONS, AND FINISH.

GENERAL NOTES:

1. COORD. WITH CIVIL FOR FINISH FLOOR ELEVATIONS.
2. FINISH GRADE TO PROVIDE POSITIVE DRAINAGE AWAY FROM BUILDING, TYP.
3. PORCHES/PATIOS TO SLOPE AT 1/48 AWAY FROM BUILDING, MAX OR AS NOTED ON THE PLANS - SEE PLANS AND CIVIL.
4. REFER TO STRUCTURAL DRAWINGS FOR ADDITIONAL SLAB AND FOUNDATION INFORMATION.
5. PLUMBING FIXTURES SHOWN ARE FOR DESIGN INTENT ONLY - CONTRACTOR TO VERIFY AND CONFIRM ALL IN-SLAB UTILITIES PRIOR TO POUR, INCLUDING BUT NOT LIMITED TO PLUMBING, GAS, ELECTRICAL, AND MECHANICAL.
6. COORDINATE WITH THE OWNER AND LOCAL CODES AND AUTHORITIES REGARDING TERMITE TREATMENT BELOW SLAB ON GRADE AREAS.

FLOOR PLAN LEGEND	
	STUD FRAMED WALLS - 2X4 @16" O.C. UNLESS NOTED OTHERWISE
	STUD FRAMED WALLS - 2X6 @16" O.C. UNLESS NOTED OTHERWISE
	BRICK/STONE VENEER - TYPE AND FINISH PER OWNER



GENERAL NOTES:

1. CARPET PILE HEIGHT TO BE 1/2" MAX.
2. REFER TO SHEET A5.2 FOR DOOR THRESHOLD DETAILS.

ARCHITECTURAL FINISH SCHEDULE					
RM #	ROOM NAME	FLOOR	BASE	WALL	CEILING
100	KITCHEN	QUARY TILE	QUARY TILE	TILE/GYP	PAINTED GYP
101	STORAGE	QUARY TILE	QUARY TILE	FRP	PAINTED GYP
102	MECHANICAL	CONCRETE	PAINTED GYP	PAINTED GYP	PAINTED GYP
103	WOMENS RR	TILE	TILE	TILE/GYP	PAINTED GYP
104	MENS RR	TILE	TILE	TILE/GYP	PAINTED GYP
201	BOOTH-1	CONCRETE	N/A	FC SIDING	FC SIDING
202	BOOTH-2	CONCRETE	N/A	FC SIDING	FC SIDING

1. PROVIDE MOISTURE RESISTANT GYPSUM WALL BOARD IN ALL RESTROOMS, MAINTENANCE ROOMS, STORAGE ROOMS, AND KITCHEN/CONCESSIONS AREAS.
2. FOR TILED WALLS, PROVIDE GYPSUM BACKER BOARD SUBSTRATE BEHIND TILE OF EQUAL THICKNESS TO SPECIFIED GYPSUM WALL BOARD. WHERE TILE IS PLACED ON RATED WALLS, CEMENTITIOUS BACKER BOARD MUST BE APPLIED ABOVE GYPSUM BOARD REQUIRED FOR FIRE RATED WALL ASSEMBLY.
3. ALL FLOORING FINISHES TO BE NON-SLIP.
4. MATERIAL TRANSITIONS TO OCCUR AT CL OF DOOR IN CLOSED POSITION OR AS NOTED ON THE INTERIOR DESIGN DRAWINGS. ALL FLOORING TRANSITIONS MUST BE ADA COMPLIANT.
5. A. INTERIOR FLOORING TRANSITIONS MUST NOT BE GREATER THAN 1/4" IN HEIGHT, OR 1/2" IN HEIGHT IF SLOPED AT 1:2 MAX.
6. B. FINISH MATERIALS FOR INTERIOR EXIT STAIRWAYS, CORRIDORS, AND EXIT PASSAGEWAYS TO BE MIN. CLASS-B, FINISH MATERIALS WITHIN ROOMS AND UNLOCKED SPACES TO BE MIN. CLASS-B, FINISH MATERIALS. 803.15
7. ALL GYPSUM WALL AND CEILING BOARD TO BE 5/8" THICK UNLESS NOTED OTHERWISE OR AS REQUIRED BY RATED ASSEMBLIES.

KITCHEN EQUIPMENT SCHEDULE:		
<u>DESIGNATION:</u>	<u>EQUIPMENT DESCRIPTION:</u>	<u>MANUFACTURER/MODEL:</u>
K1	REACH IN REFRIGERATOR	WHIRLPOOL/WSRS7R18DM
K2	REACH IN FREEZER	WHIRLPOOL/WSZS7L18D
K3	ICE MACHINE	MANITOWOC/RNP0620W
K4	THREE COMPARTMENT SINK	FALCON/E3C-10X14R-15
K5	MOBILE HEATED CABINET	ATOSA/ATHC-18P
K6	WORK TABLE	FALCON/WT-(SIZE AS NOTED)
K7	COUNTERTOP FOOD PAN WARMER	FALCON/ZCK165B
K8	POPCORN MACHINE	WINCO/111147
K9	BEVERAGE DISPENSER	BUNN/SET00.0203
K10	COFFEE BREWER	BUNN/12950.0212
K11	HAND SINK	REGENCY/660HS175P

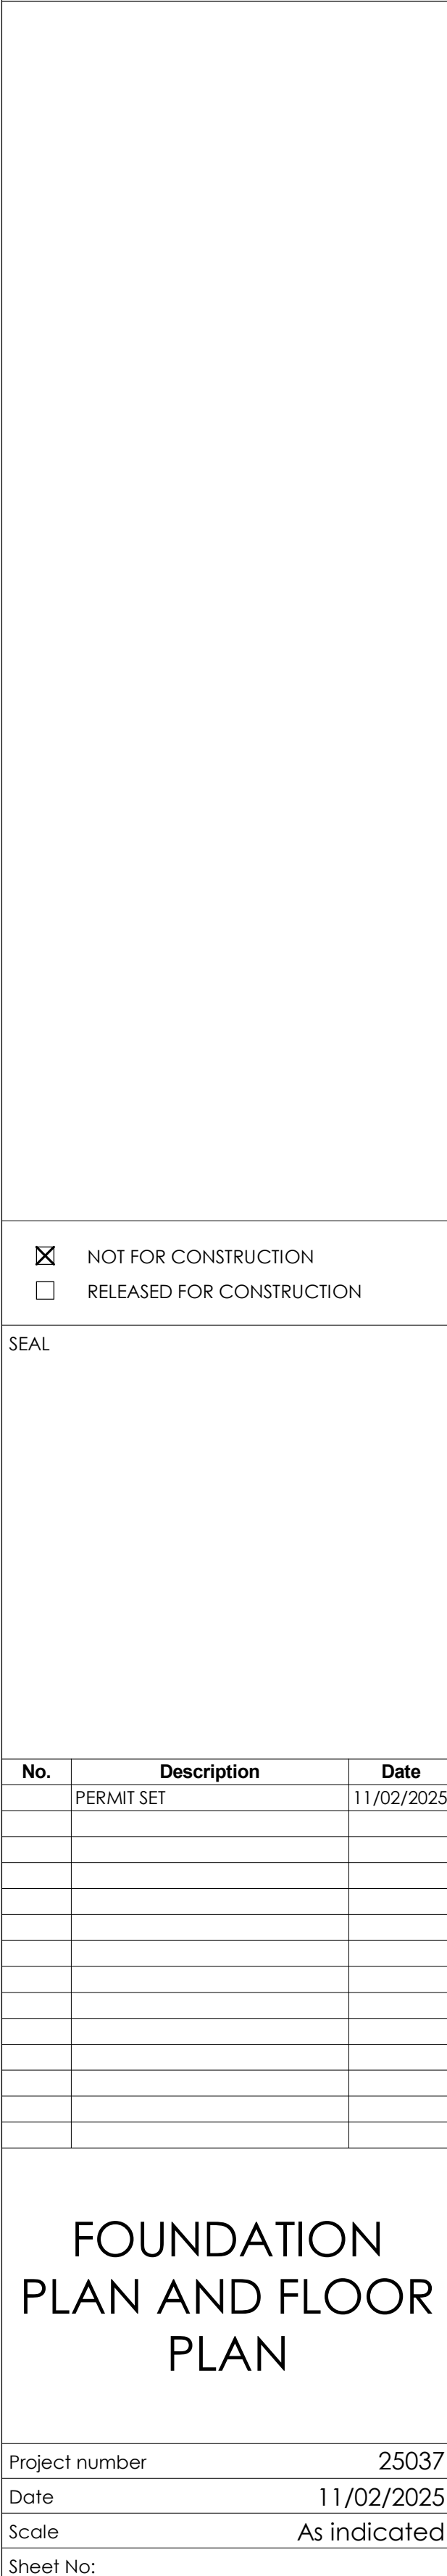 

Project number	25037
Date	11/02/2025
Scale	As indicated

A1.0



FOUNDATION PLAN LEGEND	
	CONCRETE SLAB-ON-GRADE
	WOOD FRAMED WALLS - SEE FLOOR PLANS
	SLAB STEP - SEE CIVIL
	FD: FLOOR DRAIN - REFER TO PLUMBING DRAWINGS FOR SIZING, LOCATIONS, AND FINISH.
GENERAL NOTES: 1. COORD. WITH CIVIL FOR FINISH FLOOR ELEVATIONS. 2. FINISH GRADE TO PROVIDE POSITIVE DRAINAGE AWAY FROM BUILDING, TYP. 3. PORCHES/PATIOS TO SLOPE AT 1/48 AWAY FROM BUILDING, MAX OR AS NOTED ON THE PLANS - SEE PLANS AND CIVIL. 4. REFER TO STRUCTURAL DRAWINGS FOR ADDITIONAL SLAB AND FOUNDATION INFORMATION. 5. PLUMBING FIXTURES SHOWN ARE FOR DESIGN INTENT ONLY - CONTRACTOR TO VERIFY AND CONFIRM ALL IN-SLAB UTILITIES PRIOR TO POUR, INCLUDING BUT NOT LIMITED TO PLUMBING, GAS, ELECTRICAL, AND MECHANICAL. 6. COORDINATE WITH THE OWNER AND LOCAL CODES AND AUTHORITIES REGARDING TERMITE TREATMENT BELOW SLAB ON GRADE AREAS.	

FLOOR PLAN LEGEND	
	STUD FRAMED WALLS - 2X4 @16" O.C. UNLESS NOTED OTHERWISE
	STUD FRAMED WALLS - 2X6 @16" O.C. UNLESS NOTED OTHERWISE
	BRICK/STONE VENEER - TYPE AND FINISH PER OWNER

ROOF PLAN NOTES	
1. ROOF DESIGN IS ASSUMED TO BE PREENGINEERED WOOD TRUSSES. TRUSS MANUFACTURER TO SUBMIT SIGNED AND SEALED ENGINEERING DRAWINGS FOR TRUSS DESIGN TO BUILDER AND AHJ FOR REVIEW AND COMMENT PRIOR TO FABRICATION.	4. REFER TO ARCHITECTURAL DETAILS FOR ADDITIONAL INFORMATION ON ROOF ASSEMBLY, SOFFIT AND RAKE CONDITION, FLASHINGS, AND OTHER ASSOCIATED ROOFING ELEMENTS.
2. MINIMIZE ROOF PENETRATIONS WHERE POSSIBLE BY COMBINING PLUMBING VENTS, MECHANICAL EXHAUST/INTAKE, ETC. WHERE POSSIBLE.	5. PROVIDE HIGH-TEMP ICE AND WATER SHIELD BELOW ALL METAL ROOF AREAS.
3. ALL ROOF AREAS TO RECEIVE PREFINISHED ALUMINUM COPING CAPS, REFER TO ARCHITECTURAL DETAILS FOR ADDITIONAL INFORMATION.	6. PROVIDE THRU-WALL SCUPPER AND ROUND DOWNSPOUTS AS INDICATED ON THE ROOF PLANS. COLOR PER ARCHITECT.

GENERAL NOTES:

 1. COORD. WITH CIVIL FOR FINISH FLOOR ELEVATIONS.
2. FINISH FLOOR TO PROVIDE POSITIVE DRAINAGE AWAY FROM BUILDING, TYP.
3. PORCHES/PATIOS TO SLOPE AT 1/48 AWAY FROM BUILDING, MAX OR AS NOTED ON THE PLANS - SEE PLANS AND CIVIL.
4. REFER TO STRUCTURAL DRAWINGS FOR ADDITIONAL SLAB AND FOUNDATION INFORMATION.
5. PLUMBING FIXTURES SHOWN ARE FOR DESIGN INTENT ONLY - CONTRACTOR TO VERIFY AND CONFIRM ALL IN-SLAB UTILITIES PRIOR TO POUR, INCLUDING BUT NOT LIMITED TO PLUMBING, GAS, ELECTRICAL, AND MECHANICAL.
6. COORDINATE WITH THE OWNER AND LOCAL CODES AND AUTHORITIES REGARDING TERMITE TREATMENT BELOW SLAB ON GRADE AREAS.

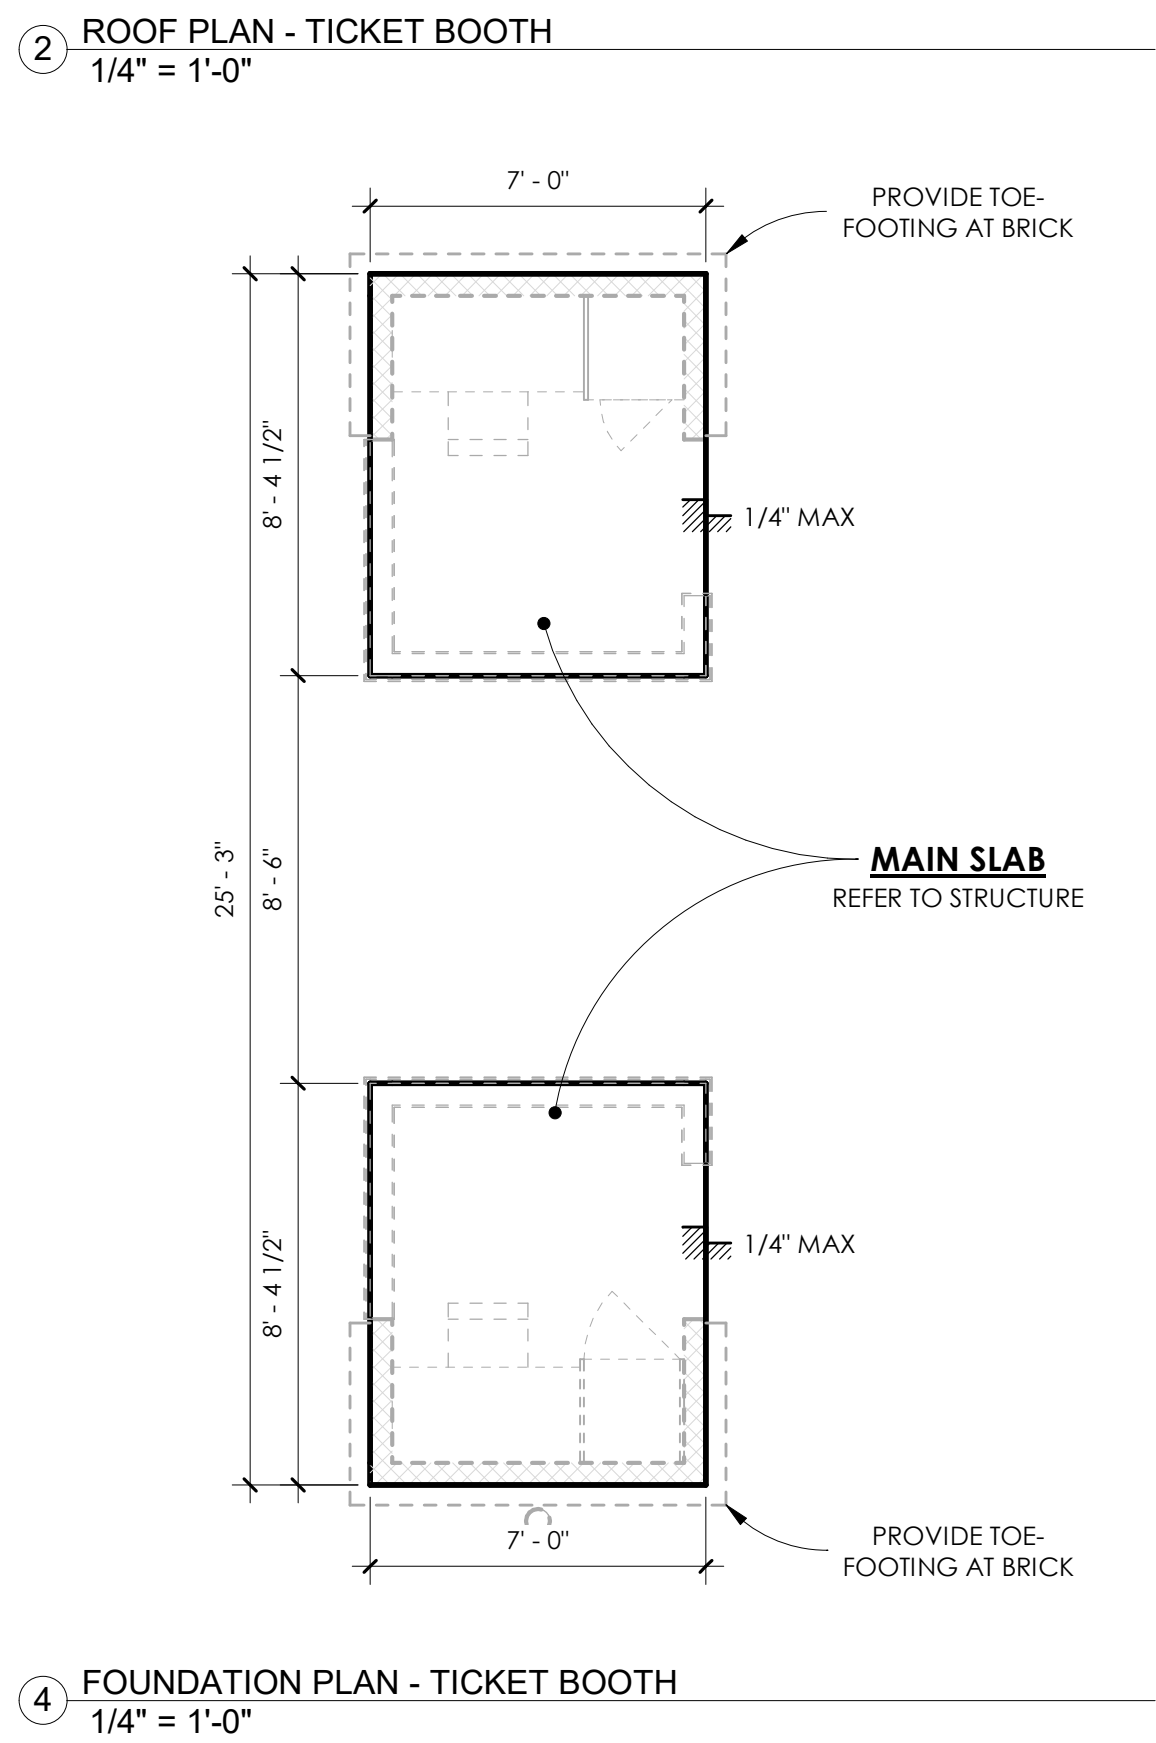

DUNWOODY HIGH SCHOOL - CONCESSIONS
5035 VERMACK RD
DUNWOODY, GA 30338

SEAL

[illegible]

ROOF PLAN &
TICKET BOOTH
PLANS

Project number	25037
Date	11/02/2025
Scale	1/4" = 1'-0"

Sheet No:






A1.1

Project number	25037
Date	11/02/2025
Scale	1/4" = 1'-0"
Sheet No:	

A1.1

11/2/2025 4:47:51 PM

     CEILING PLAN LEGEND

	GYPSUM WALL BOARD CEILING
	HARDIE ARTISAN V-GROOVE SIDING W/7" EXPOSURE - ORIENTATION AS SHOWN
	SUPPLY AIR DIFFUSER
	RETURN AIR DIFFUSER
	EXHAUST AIR DIFFUSER
	RECESSED DOWNLIGHT
	PENDANT LIGHT
	WALL SCONCE
	EXIT SIGN
	SMOKE DETECTOR
	RECESSED LINEAR LED LIGHT

1. LIGHTING DESIGN AND FIXTURE SPECIFICATION PROVIDED BY SESCO LIGHTING, P.O.C. IS KATIE KENNEDY 407-455-3665, KKENNEDY@SESCOLIGHTING.COM.
2. REFER TO LIGHTING DESIGN DRAWINGS FOR INFORMATION PERTAINING TO THE LIGHTING CONTROL SYSTEM, AND FIXTURE SPECIFICATION.
3. ALL FIXTURE FINISHES TO BE COORDINATED WITH THE OWNER/INTERIOR DESIGNER.

1. REFER TO A0.0 FOR GENERAL CONSTRUCTION NOTES.
2. REFER TO ID, STRUCTURAL, ELECTRICAL, MECHANICAL, AND PLUMBING DRAWINGS FOR ADDITIONAL INFORMATION.
3. GC TO COORDINATE FIRE PROTECTION DEVICE DESIGN (INCLUDING BUT NOT LIMITED TO SPRINKLERS, SMOKE DETECTORS, STROBES, AND ALARMS) WITH LIGHTING AND MECHANICAL LAYOUTS. DEVICES MUST BE PLACED IN ALIGNMENT WITH LIGHTING WHERE POSSIBLE.



SEAL

Project number	25037
Date	11/02/2025
Scale	1/4" = 1'-0"
Sheet No:	

A2.0

11/2/2025 4:47:52 PM




DUNWOODY HIGH SCHOOL - CONCESSIONS
5035 VERMACK RD
DUNWOODY, GA 30338

<u>DESIGNATION:</u>	<u>DESCRIPTION:</u>	<u>MANUFACTURER/MODEL:</u>	<u>FINISH:</u>
GB18	GRAB BAR - 18"	BOBRICK B-9806 X 18	SATIN STAINLESS STEEL
GB24	GRAB BAR - 24"	BOBRICK B-9806 X 24	SATIN STAINLESS STEEL
GB36	GRAB BAR - 36"	BOBRICK B-9806 X 36	SATIN STAINLESS STEEL
GB42	GRAB BAR - 42"	BOBRICK B-9806 X 42	SATIN STAINLESS STEEL
PTD1	LARGE RECESSED C-FOLD PAPER TOWEL DISPENSER AND TRASH	BOBRICK B-38034	SATIN STAINLESS STEEL
TP1	RECESSED TOILET TISSUE, SEAT COVER, AND WASTE UNIT	BOBRICK B-3092 OR B-3091	SATIN STAINLESS STEEL
TP2	SURFACE MOUNTED TOILET TISSUE, SEAT COVER, AND WASTE UNIT	BOBRICK B-30919 OR B-30929	SATIN STAINLESS STEEL
RRT	RESTROOM TOILET, PROVIDE MATCHING TOILET SEAT	KOHLER K-PR96057-T3D	WHITE
RRU	RESTROOM URINAL	KOHLER K-PR20713-T1D-NA	WHITE
RRS	RESTROOM UNDERMOUNT VANITY SINK	KOHLER K-8189	WHITE
WMS	BASIS OF DESIGN WALL MOUNTED SINK	KOHLER K-2084-0	WHITE
FSD-1	BASIS OF DESIGN FAUCET AND SOAP DISPENSER	BOBRICK B-8876	POLISHED NICKEL
FSD-2	BASIS OF DESIGN FAUCET	DELTA DEMD-321LF	CHROME
FSD-3	BASIS OF DESIGN WALL MOUNT SOAP DISPENSER	BOBRICK B-2012.MBLK	MATTE BLACK
VM1	WELDED FRAME VANITY MIRROR	BOBRICK B-290 2448.MBLK	MATTE BLACK
HD	RECESSED HAND DRYER	BOBRICK B-3725	SATIN STAINLESS STEEL
MS	SERVICE / MOP SINK	KOHLER K-6710-0	WHITE

1. FIXTURES NOTED ABOVE ARE TO SERVE AS THE BASIS OF DESIGN AND ARE INTENDED TO CORRELATE TO THE ADJACENT FIXTURE MOUNTING DIAGRAMS. SUBSTITUTION OF A SIMILAR OR EQUAL PRODUCT IS ACCEPTABLE IF ALL RELEVANT ACCESSIBILITY REQUIREMENTS ARE MET, PRODUCT IS OF EQUAL OR GREATER QUALITY, AND SUBSTITUTION IS ACCEPTABLE TO THE OWNER. CONFIRM ALL FINISHES WITH THE OWNER/INTERIOR DESIGNER.

2. PLUMBING FIXTURES SPECIFIED ABOVE ARE FOR BASIC DESIGN ONLY AND MAY NOT CONTAIN ALL RELEVANT ACCESSIBILITY COMPONENTS REQUIRED FOR A FULL AND COMPLETE SYSTEM. REFER TO THE PLUMBING DRAWINGS FOR ADDITIONAL INFORMATION, VARIETY/SINK AND FAUCET DESIGN CONTAINED HEREIN IS FOR BASIS OF DESIGN ONLY. FINAL PRODUCTS, FINISHES, AND DESIGN FOR THESE ELEMENTS MUST BE COORDINATED WITH THE OWNER AND INTERIOR DESIGNER.



3. ALL EXPOSED PLUMBING BELOW SINKS TO RECEIVE PREFORMED PVC COVERS IN COMPLIANCE WITH ADA SECTION 606.5.

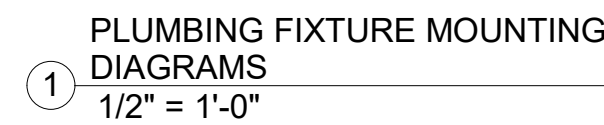


RESTROOM DETAILS


Project number	25037
Date	11/02/2025
Scale	As indicated
Sheet No:	

  A2.1


EXTERIOR LEGEND		EXTERIOR KEYNOTES	
	FULL BRICK VENEER - COLOR TBD, GROUT COLOR TBD, RUNNING BOND PATTERN		FULL BRICK VENEER, TYPE AND FINISH PER LEGEND, PROVIDE TIE-BACKS TO STRUCTURE AS REQUIRED BY STRUCTURAL ENGINEER, BUILDING CODES, AND MANUFACTURER'S WRITTEN INSTRUCTIONS. REFER TO DETAILS FOR ADDITIONAL INFORMATION.
	FULL BRICK VENEER - COLOR TBD, GROUT COLOR TBD, STACK BOND PATTERN		FULL BRICK ROWLOCK COURSE TO MATCH VENEER, OUTSET FROM FACE OF ADJACENT BRICK AS INDICATED IN THE DETAILS. USE SOLID BRICKS AT OUTSIDE CORNERS.
	HARDIE ARTISAN V-GROOVE SIDING W/7' EXPOSURE, ORIENTATION PER ELEVATIONS, FIELD PAINTED, COLOR TBD		FULL BRICK SOLDIER COURSE TO MATCH VENEER, OUTSET FROM FACE OF ADJACENT BRICK AS INDICATED IN THE DETAILS. USE SOLID BRICKS AT OUTSIDE CORNERS.
	GLASS WITHIN DOORS/WINDOWS		FIBER CEMENT SIDING PER LEGEND, REFER TO DETAILS FOR ADDITIONAL INFORMATION.
	STANDING SEAM METAL ROOF ON HIGH-TEMP ICE AND WATER SHIELD		4/4 FIBER CEMENT TRIM BOARDS, SIZE AND LOCATIONS AS NOTED ON THE ELEVATIONS AND DETAILS.
			PREFINISHED ALUMINUM COPING CAP, PROVIDE AT PARAPET WALL AS NOTED, REFER TO DETAILS FOR ADDITIONAL INFORMATION.
			STEEL FRAME TICKET BOOTH WINDOW/GLAZING SYSTEM W/OPERABLE LOWER PANEL ON FRONT AND SIDE, 1/2" MIN THICK FULLY TEMPERED GLAZING, AND POWDER COATED FINISH ON FRAME/MULLIONS.
			STANDING SEAM METAL ROOF ON HIGH-TEMP ICE AND WATER SHIELD UNDERLAYMENT, PROVIDE CORROSION RESISTANT FLASHING AT ALL ROOF TO WALL TRANSITIONS, REFER TO DETAILS FOR ADDITIONAL INFORMATION.

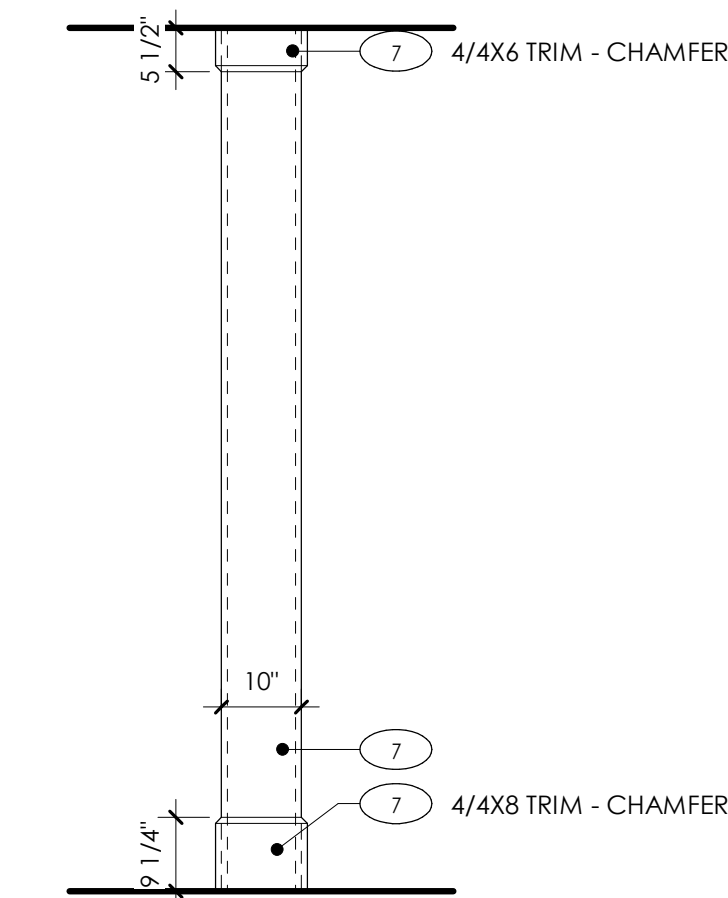


7 EXT COLUMN DETAIL
1/2" = 1'-0"

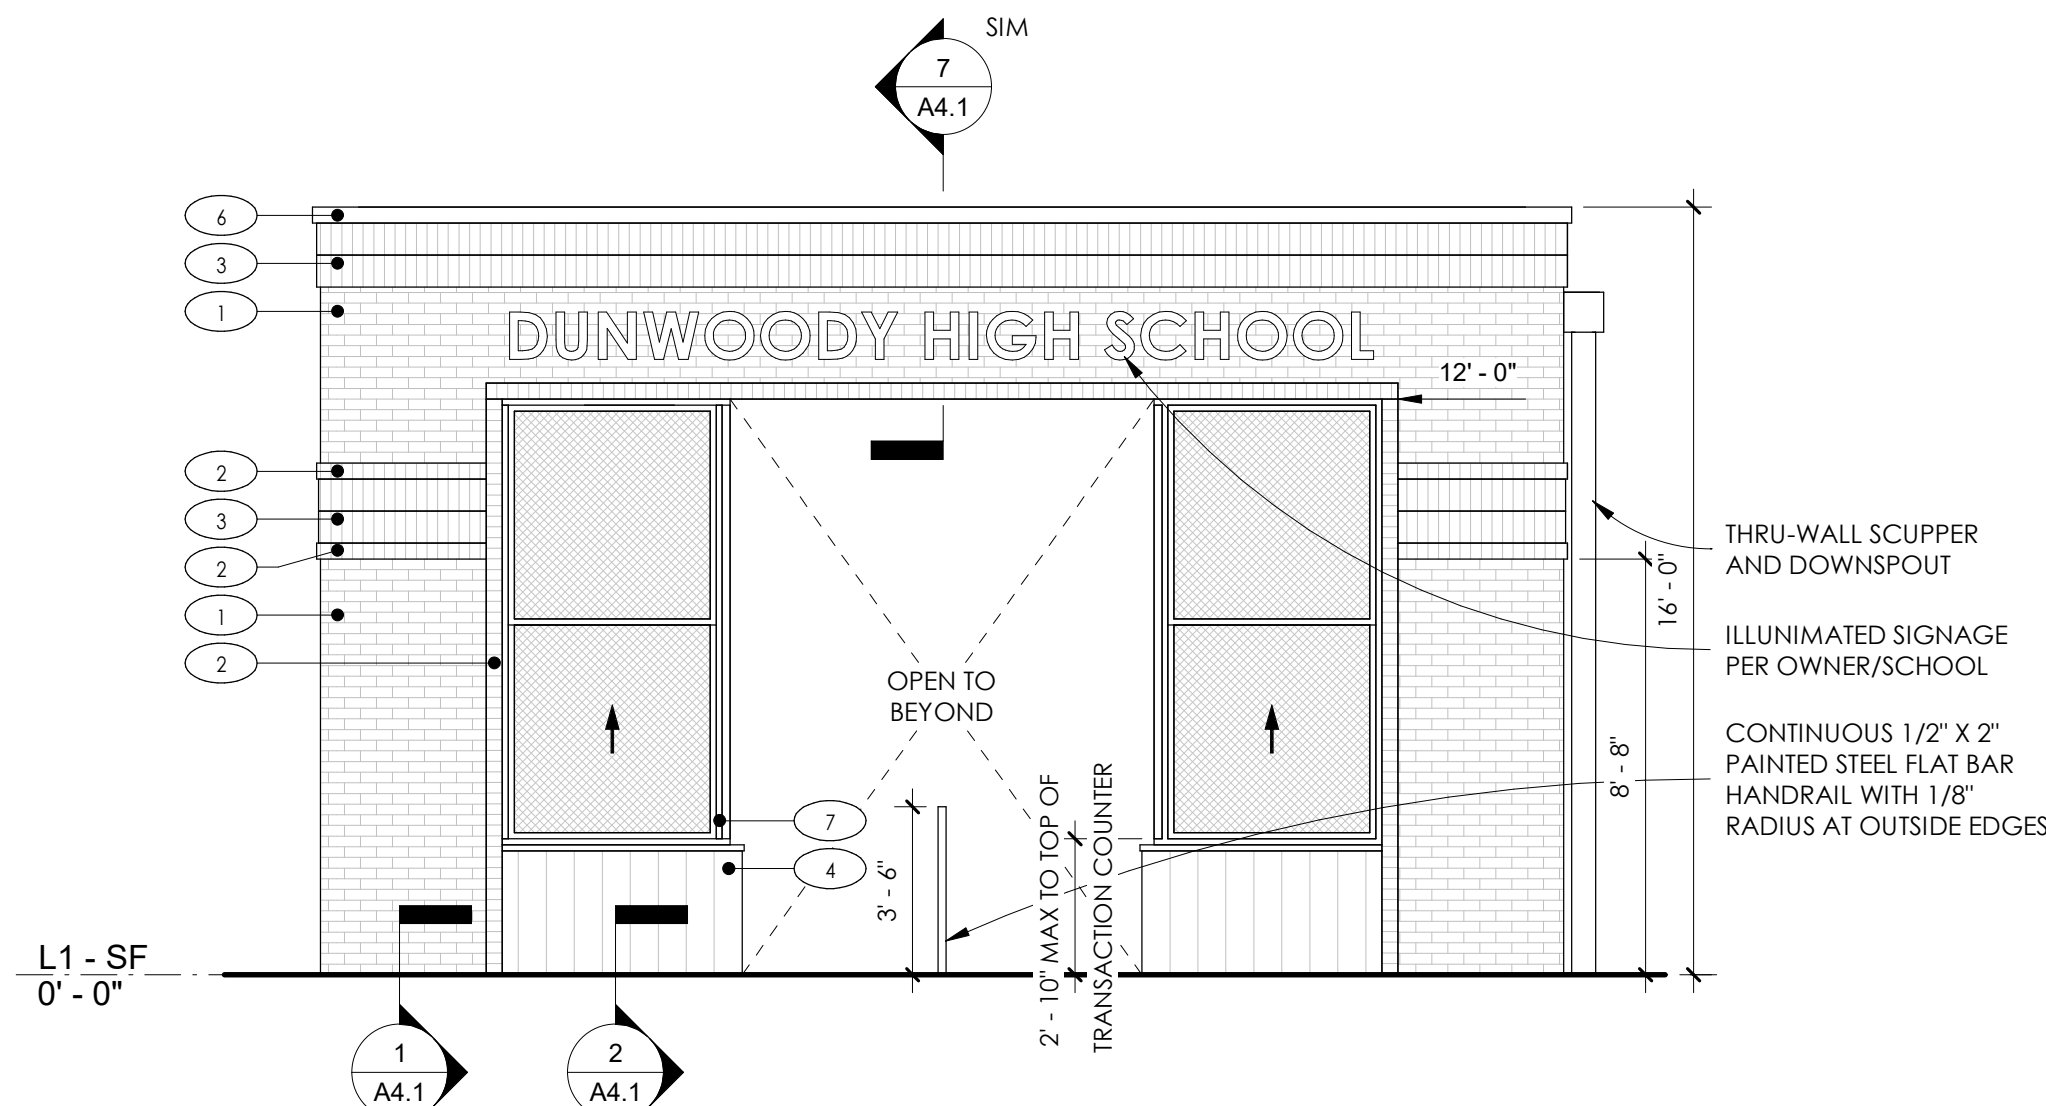


6 EXT ELEVATION- TICKET BOOTH FRONT
1/4" = 1'-0"

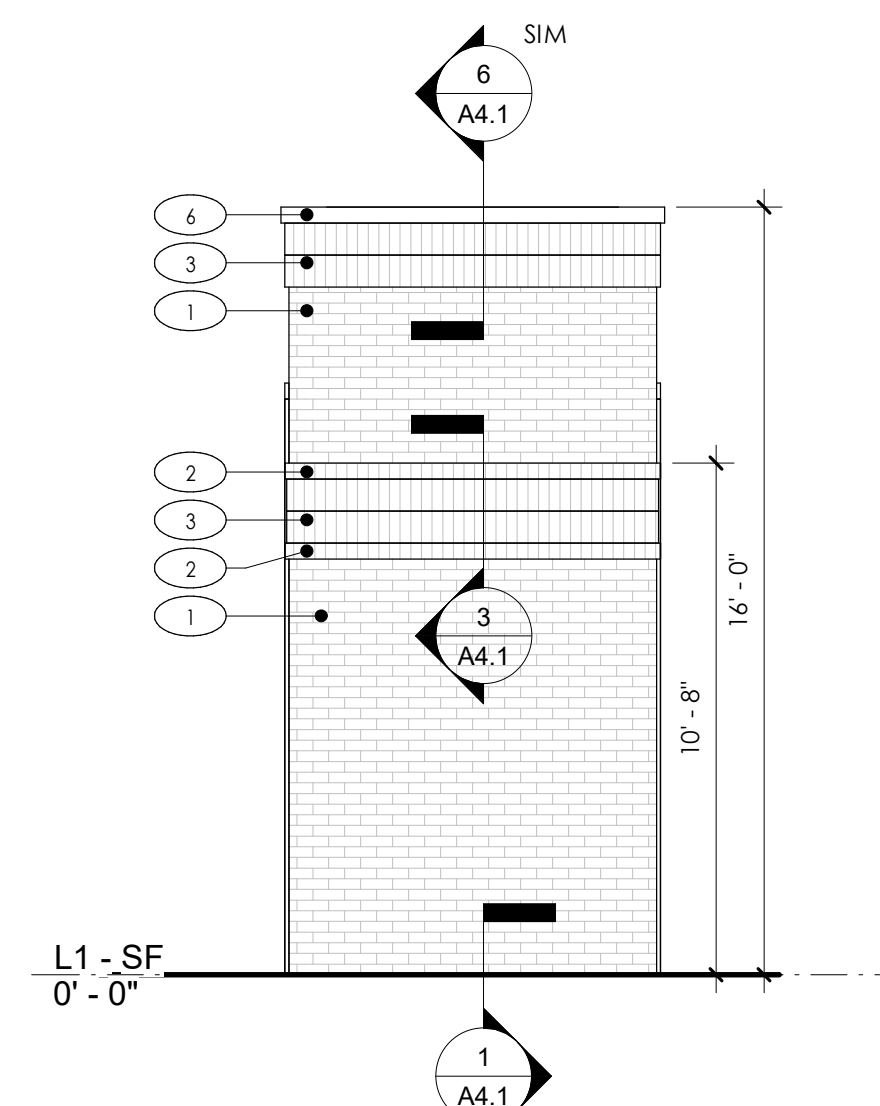


5 EXT ELEVATION - TICKET BOOTH SIDE
1/4" = 1'-0"

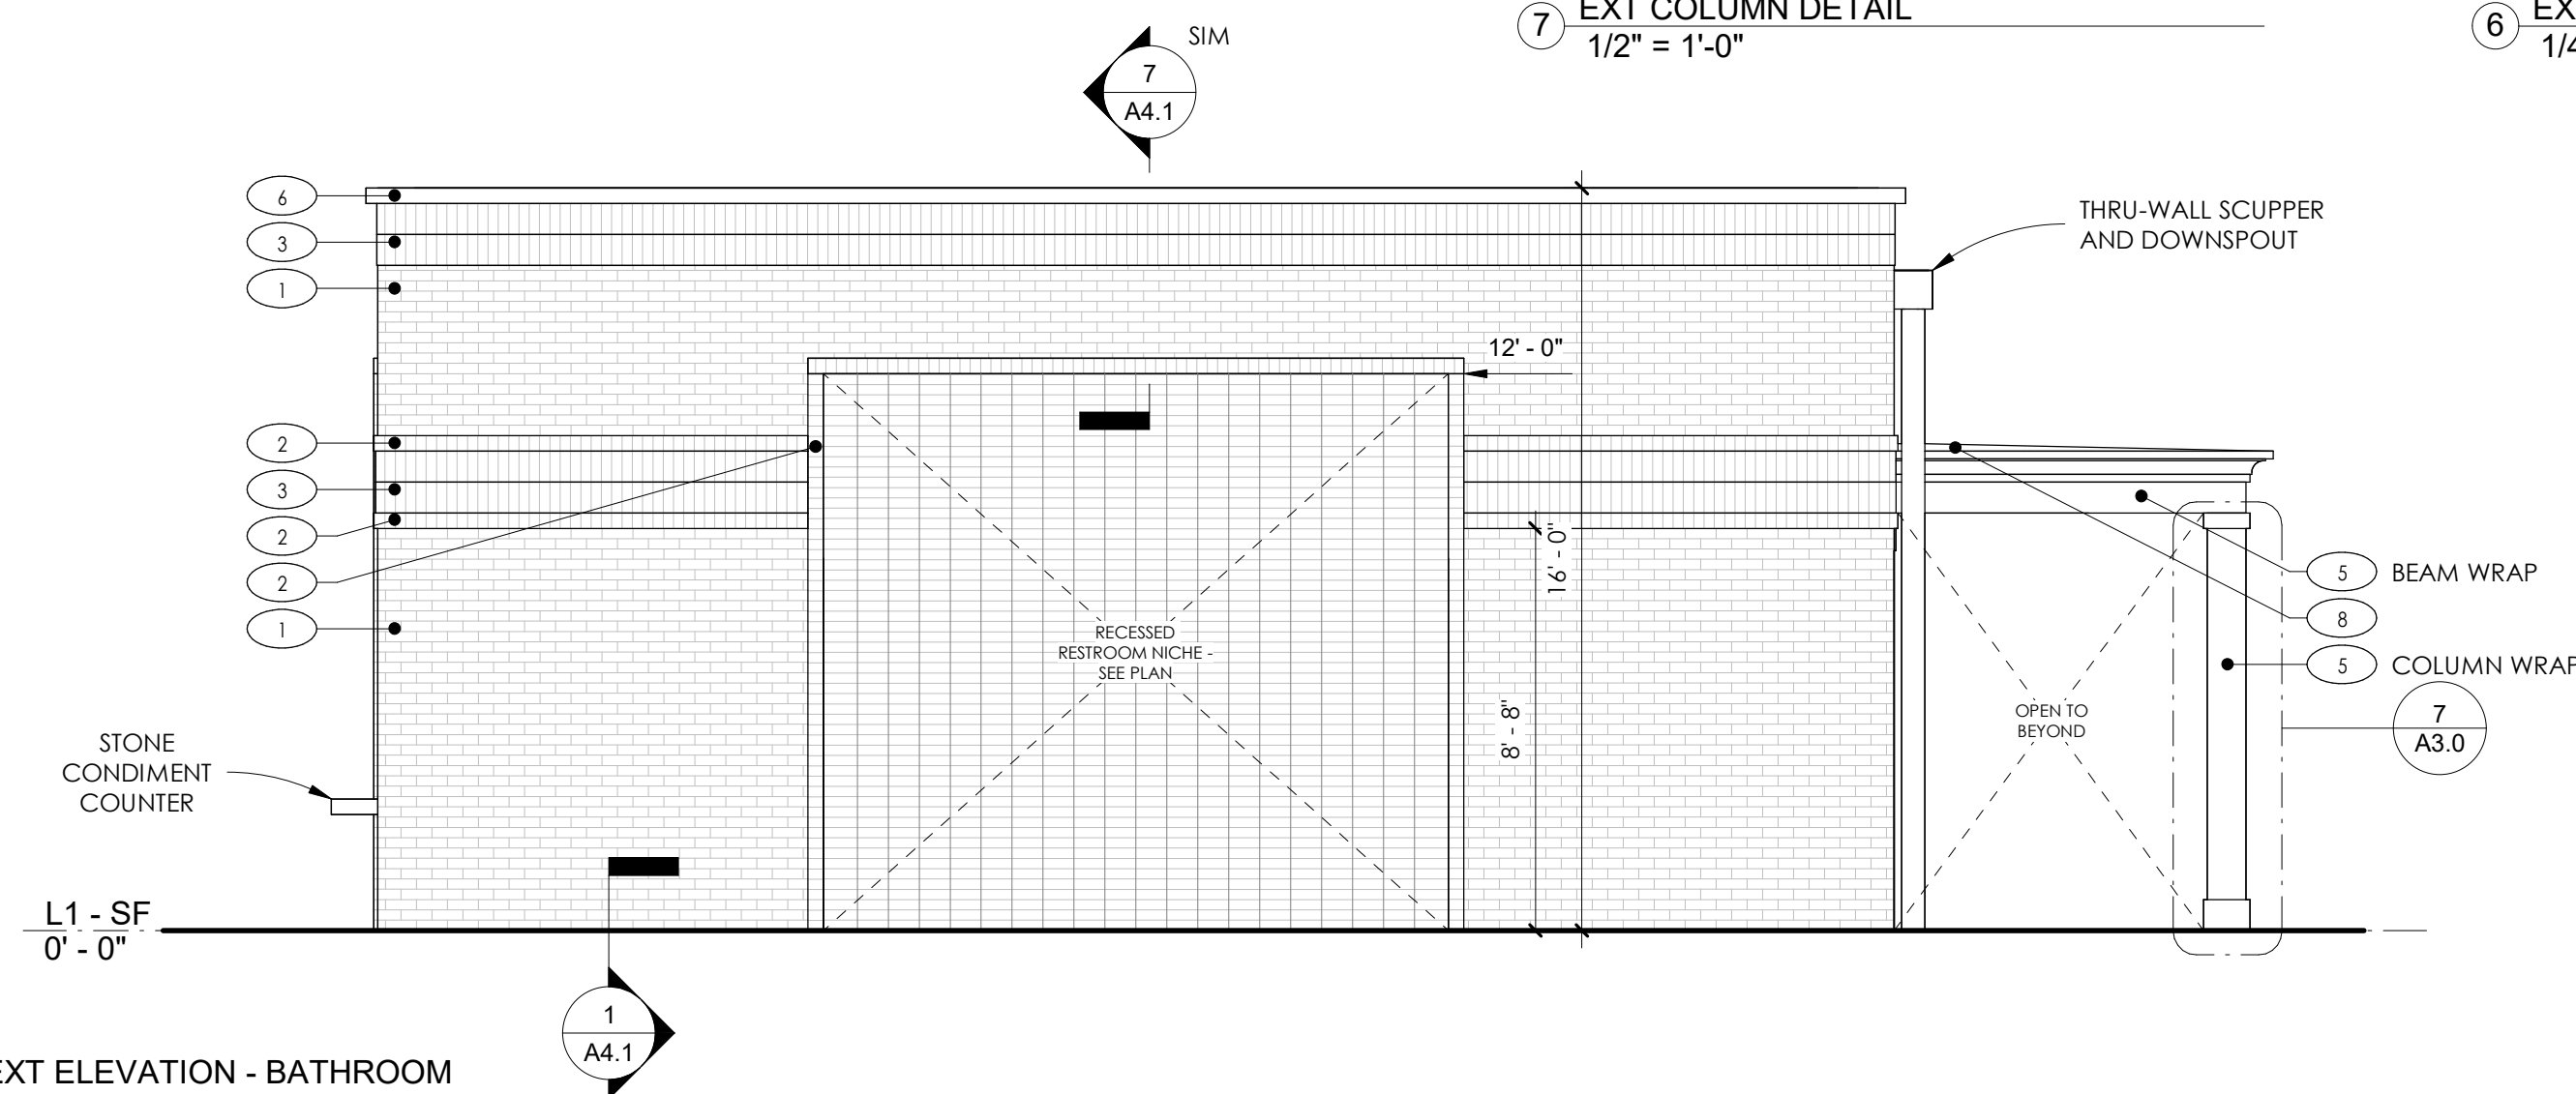


EXT ELEVATION - BATHROOM
ENTRANCE
1/4" = 1'-0"

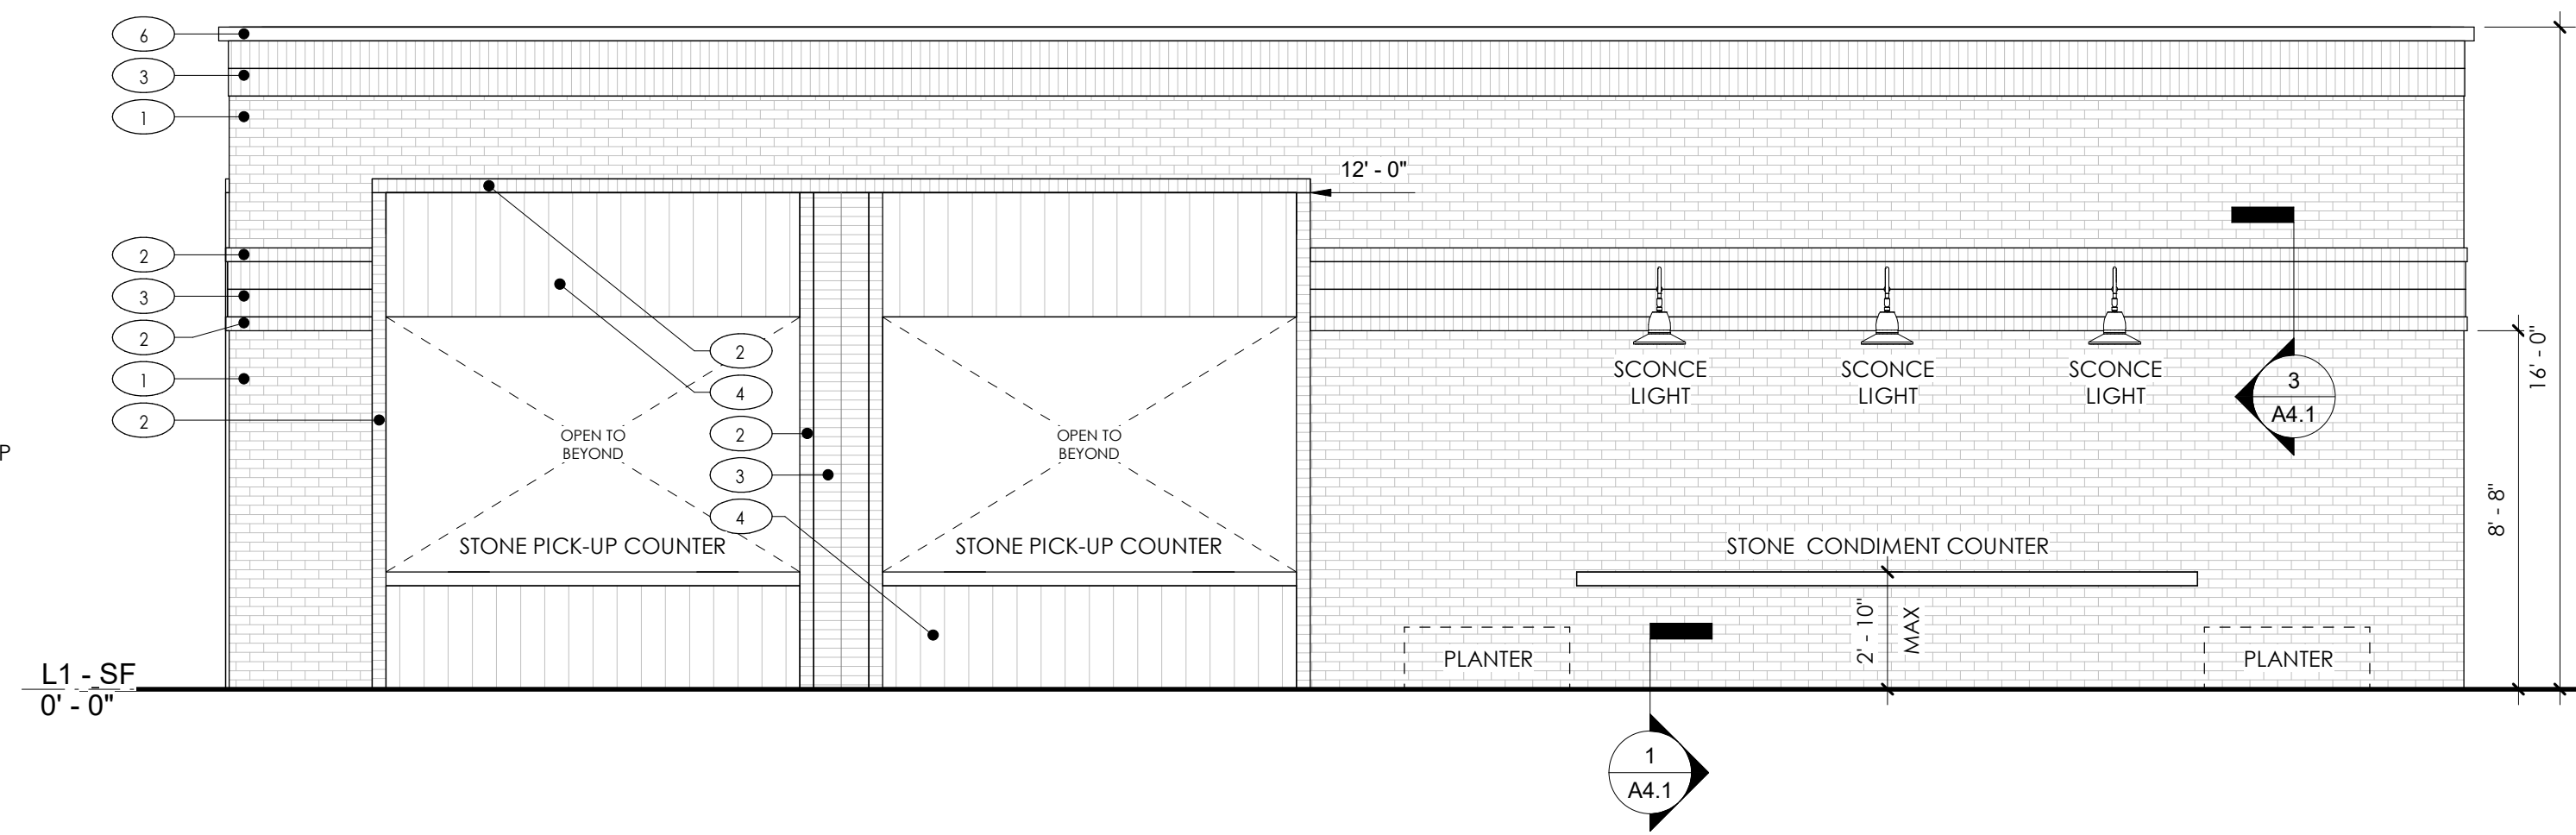

2 EXT ELEVATION - CONCESSION FRONT
1/4" = 1'-0"

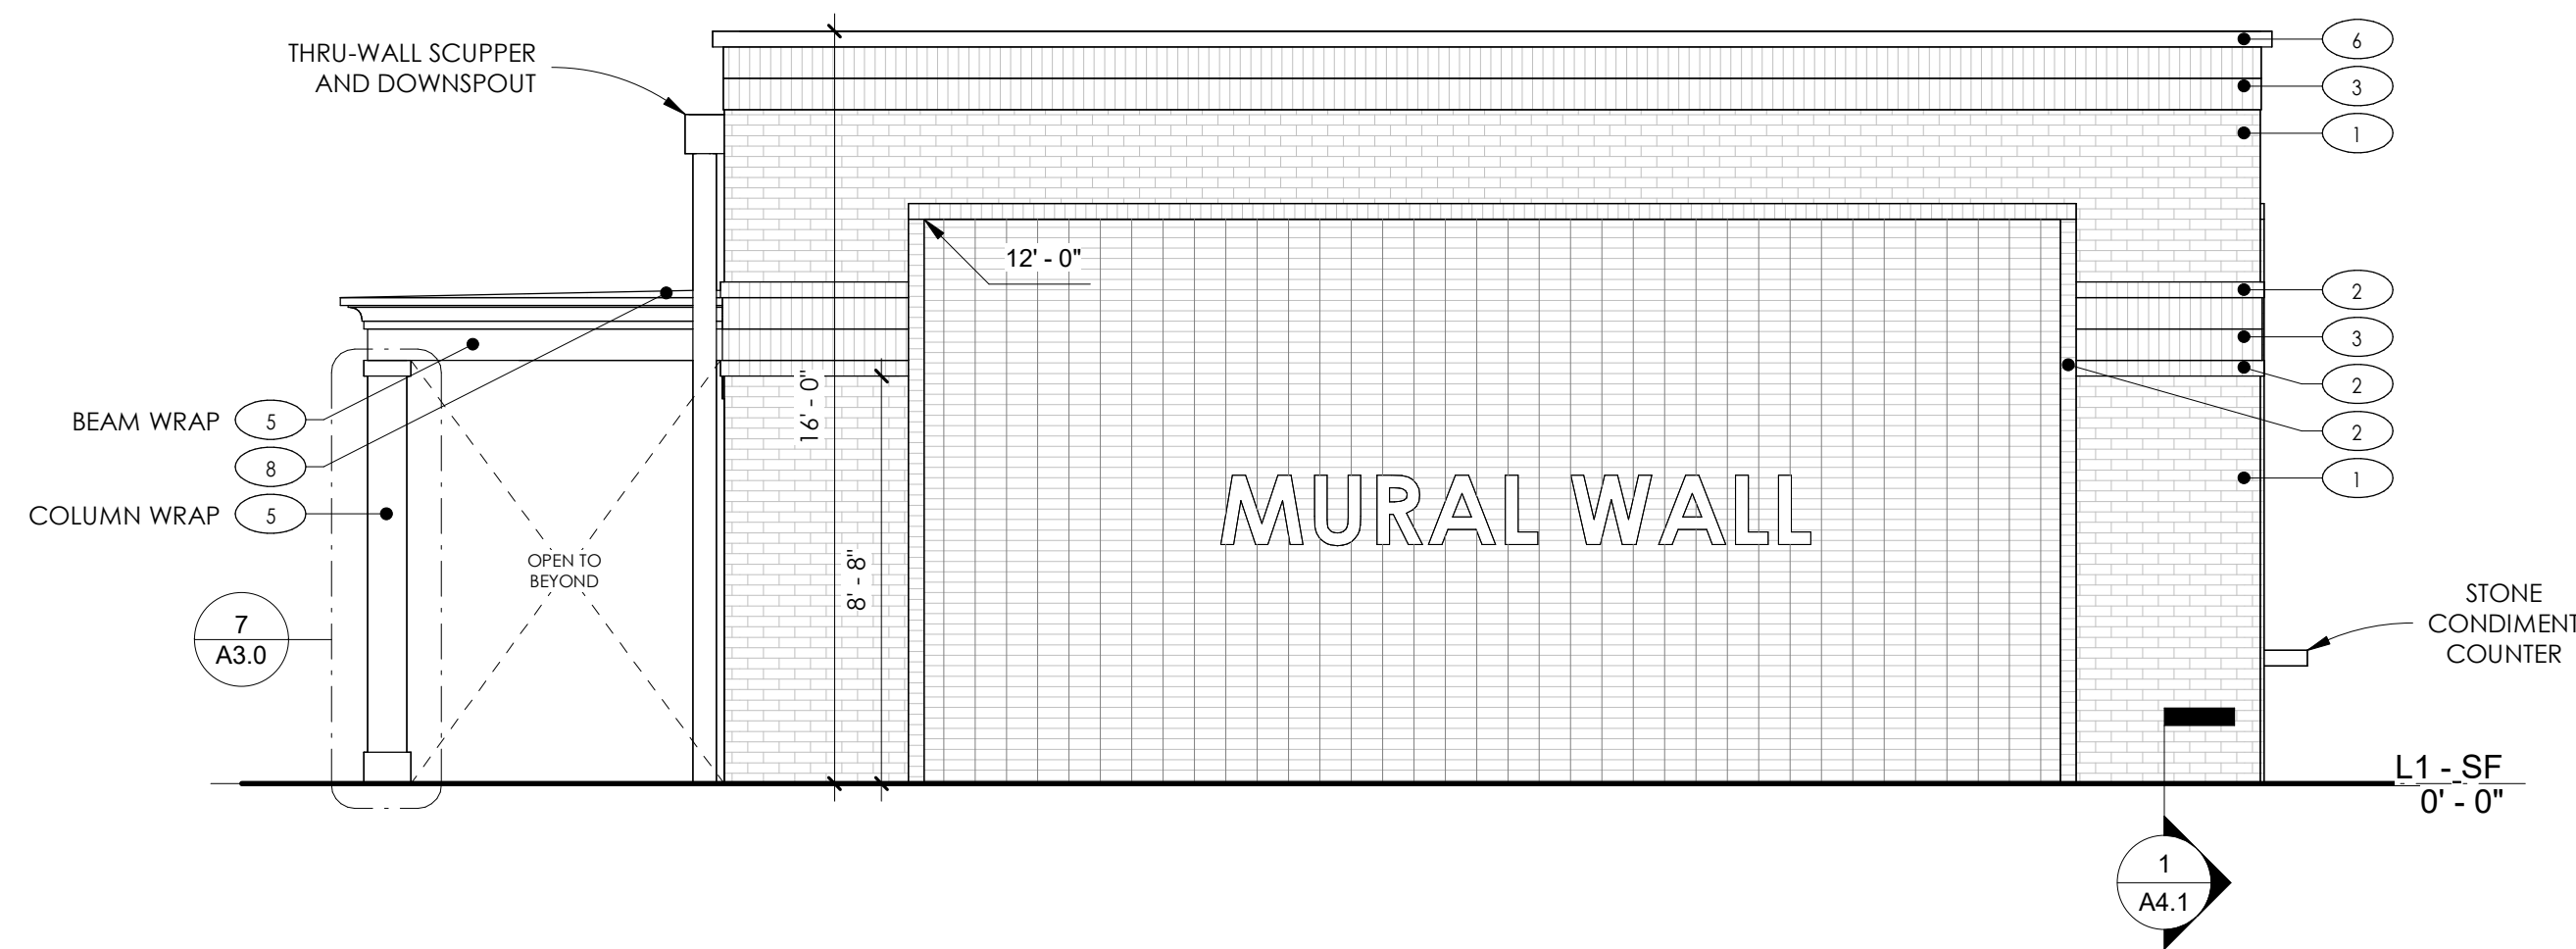

④ EXT ELEVATION - MURAL WALL
1/4" = 1'-0"

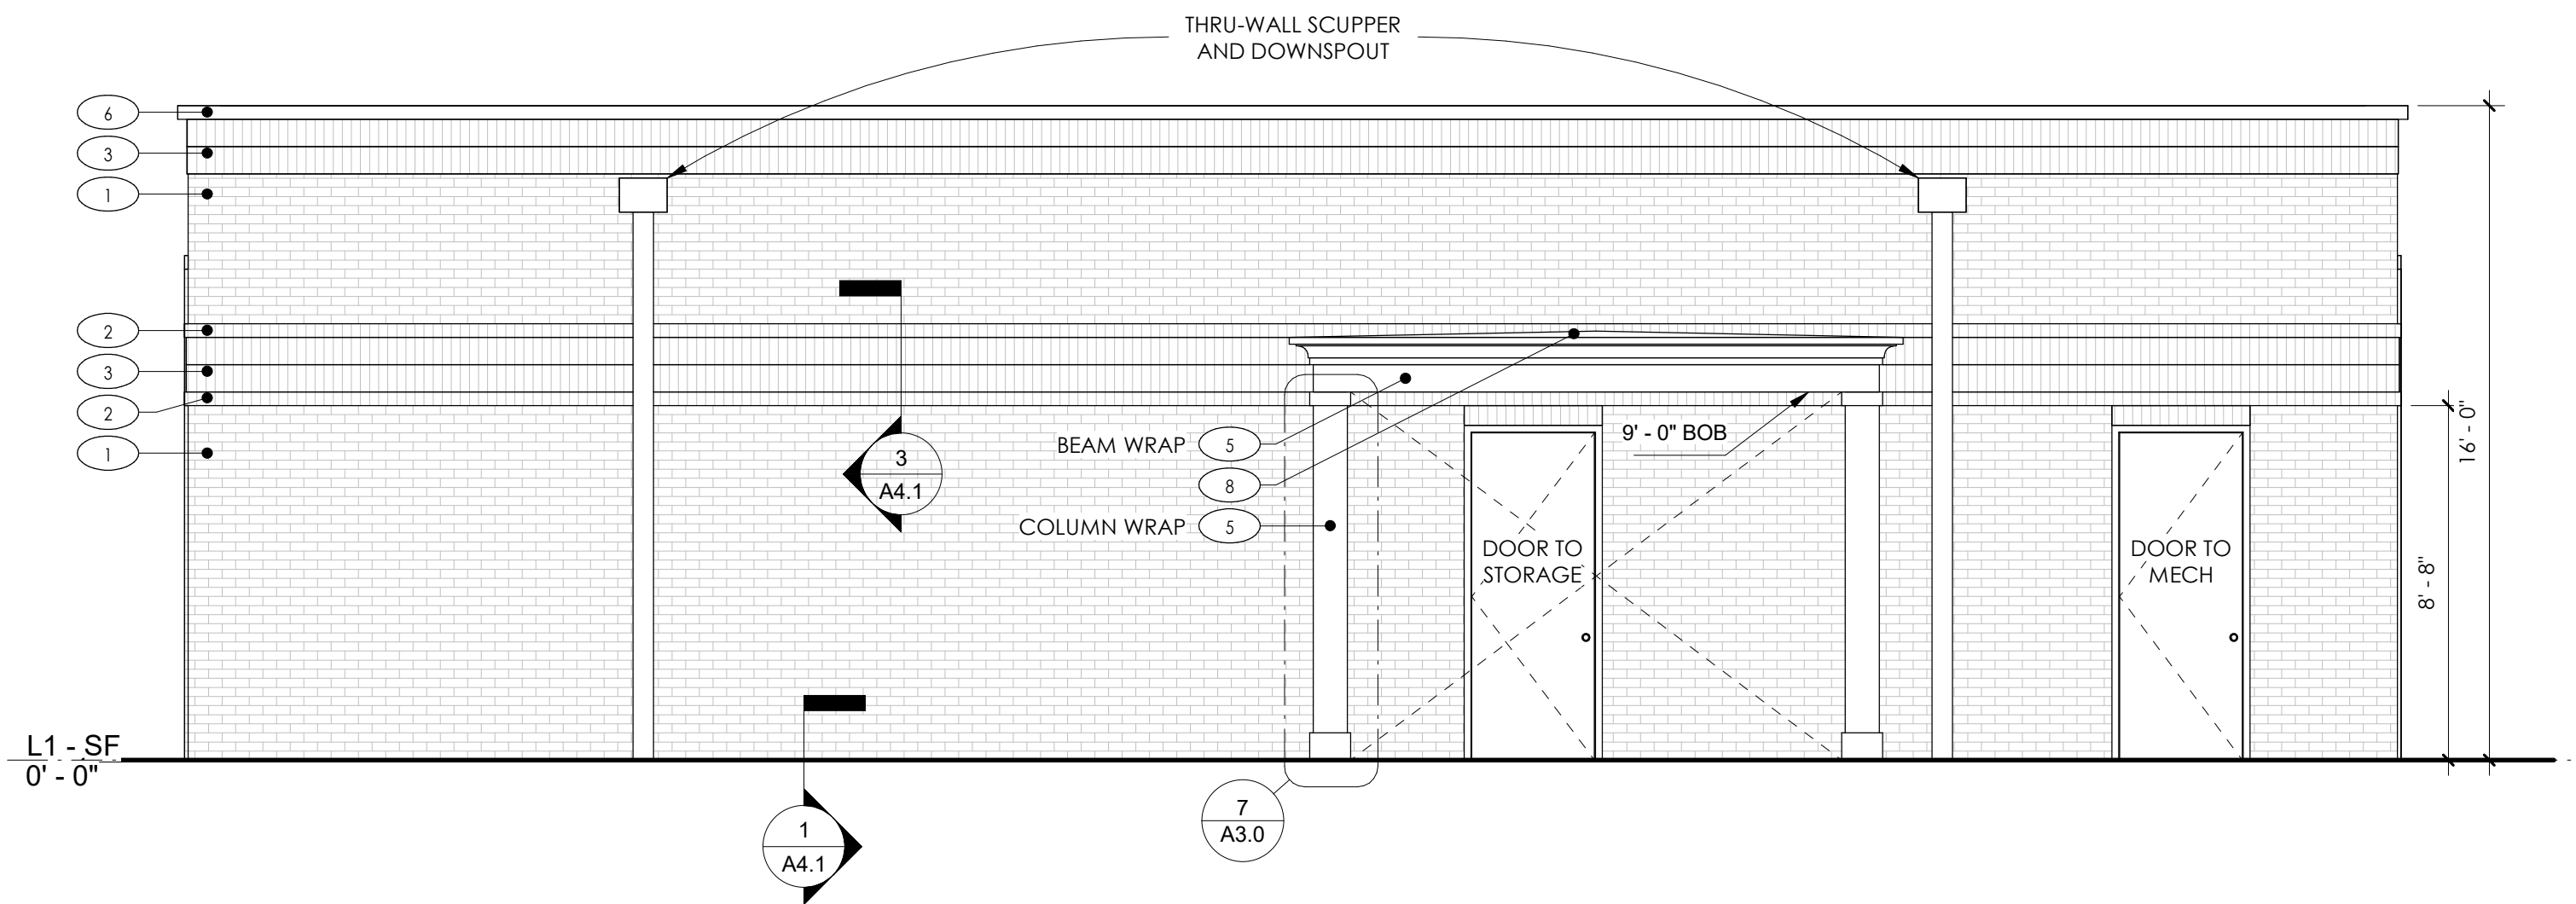

③ EXT ELEVATION - CONCESSION REAR
1/4" = 1'-0"



DUNWOODY HIGH SCHOOL - CONCESSIONS
5035 VERMACK RD
DUNWOODY, GA 30338

☒ NOT FOR CONSTRUCTION
☐ RELEASED FOR CONSTRUCTION

SEAL

[illegible]

Project number	25037
Date	11/02/2025
Scale	As indicated
Sheet No:	

A3.0

11/12/2025 1:47:56 PM



5035 VERMACK RD
DUNWOODY, GA 30338



 



SEAI

BUILDING AND WALL SECTIONS

A4.0

11/12/2025 4:47:58 PM

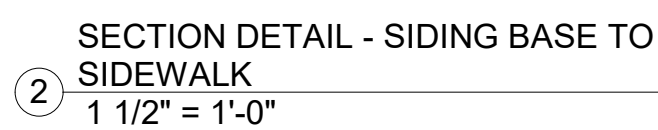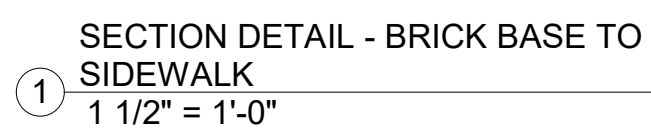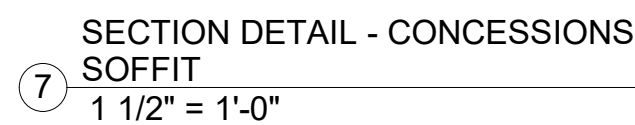


EXTERIOR DETAILS

Project number	25037
Date	11/02/2025
Scale	1 1/2" = 1'-0"
Sheet No:	

A4.1

DOOR SCHEDULE NOTES:

 1. SEE DOOR TYPE ELEVATIONS FOR DESIGN INTENT FOR EXTERIOR DOORS.
2. EXTERIOR DOORS TO BE HOLLOW METAL DOORS AND FRAMES (FULLY WELDED).
3. REFER TO FLOOR PLANS AND ELEVATIONS FOR SPECIFIC DOOR HINGE LOCATION.
4. WHERE INDICATED, PROVIDE FULLY TEMPERED GLAZING PER 2018 IBC.
5. ALL SWING DOOR HARDWARE AND THRESHOLDS MUST BE ADA COMPLIANT.
6. DOOR HARDWARE NOTES ARE FOR DESIGN INTENT ONLY AND DO NOT CONTAIN ALL REQUIRED COMPONENTS, ACCESSORIES, OR SYSTEMS NEEDED FOR A FULL AND COMPLETE INSTALLATION. BUILDER/GENERAL CONTRACTOR TO PROVIDE FULL AND COMPLETE HARDWARE PACKAGE. COORDINATE WITH THE OWNER AND INTERIOR DESIGNER ON STYLE, FINISH, AND OTHER FUNCTIONAL REQUIREMENTS.
7. BASIS OF DESIGN FOR LOCKSETS ARE SCHLAGE ALX SERIES.
 - A. HARDWARE SET 1 (HWS-1):
 - a. CLOSER, DECORATIVE PULL (BOTH SIDES).
 - B. HARDWARE SET 2 (HWS-2):
 - a. CLOSER, STOREROOM LOCKSET.



⑥ HEAD DETAILS
1 1/2" = 1'-0"



③ SILL DETAILS
3" = 1'-0"

11/2/2025 4:48:00 PM